


Uniontown Baptist Church

Bathroom Renovation Plan

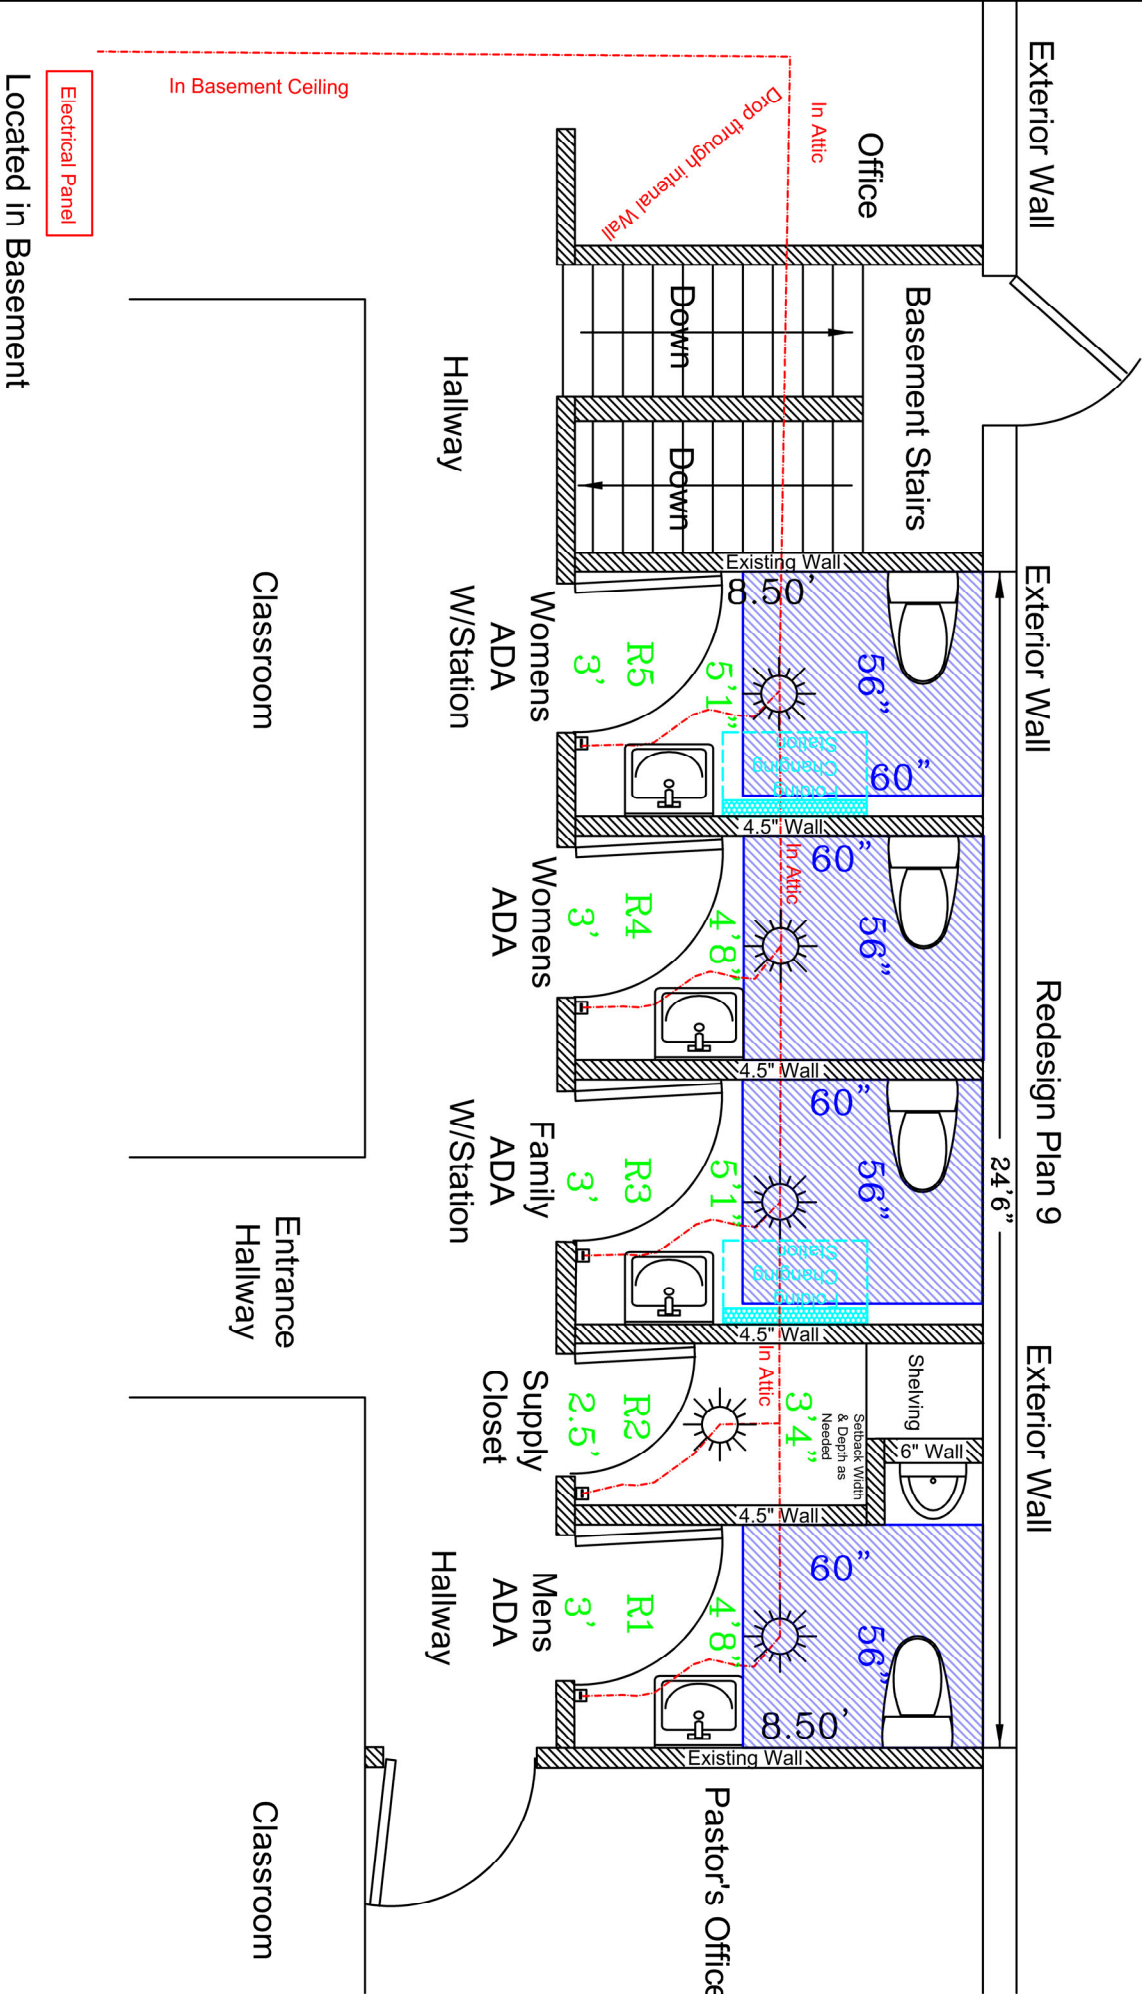

Construction Order:
Build Room 1 prior to demolition of existing Men's and Women's Restrooms for use during remaining construction:

Construction Plan:
Current Space Men's, Women's Restrooms, Closet, 210 square feet
New Internal Walls using drywall bathroom rated (See Diagram)
Repair floor plywood as needed.
Ceiling Tile to be removed Replaced with drywall bathroom rated .
Existing Fiberglass Insulation rolled back and reused if possible, replaced as needed.
Replace existing flooring with new vinyl flooring.
Steel entry doors with locking level handles.

Plumbing Plan:
ADA Complaint (See Diagram) Including Grab Bars, Wall Sinks, Urinal
Install required check flow valve on public water line.

Electric Plan:
New dedicated circuit of 14/2 wire with ground to 5 new ceiling lights, switches, and 4 exhausted fans meeting minnumal CFM requirements operated with ceiling light switch, vented through soffit.
No electrical outlets or dryers to be installed in Restrooms. Outlet to be installed in Supply Closet.

HVAC Plan:
Relocate 3 existing floor vents and install 2 additional floor vents.

Drawn By: Charles R Harkness
Deacon of Property
Date 12/8/2025